


START

91118901772


0010210
1 of 2

EQUIPMENT LIST			
ITEM NO	EQUIPMENT NUMBER	HEIGHT FEET	DESCRIPTION

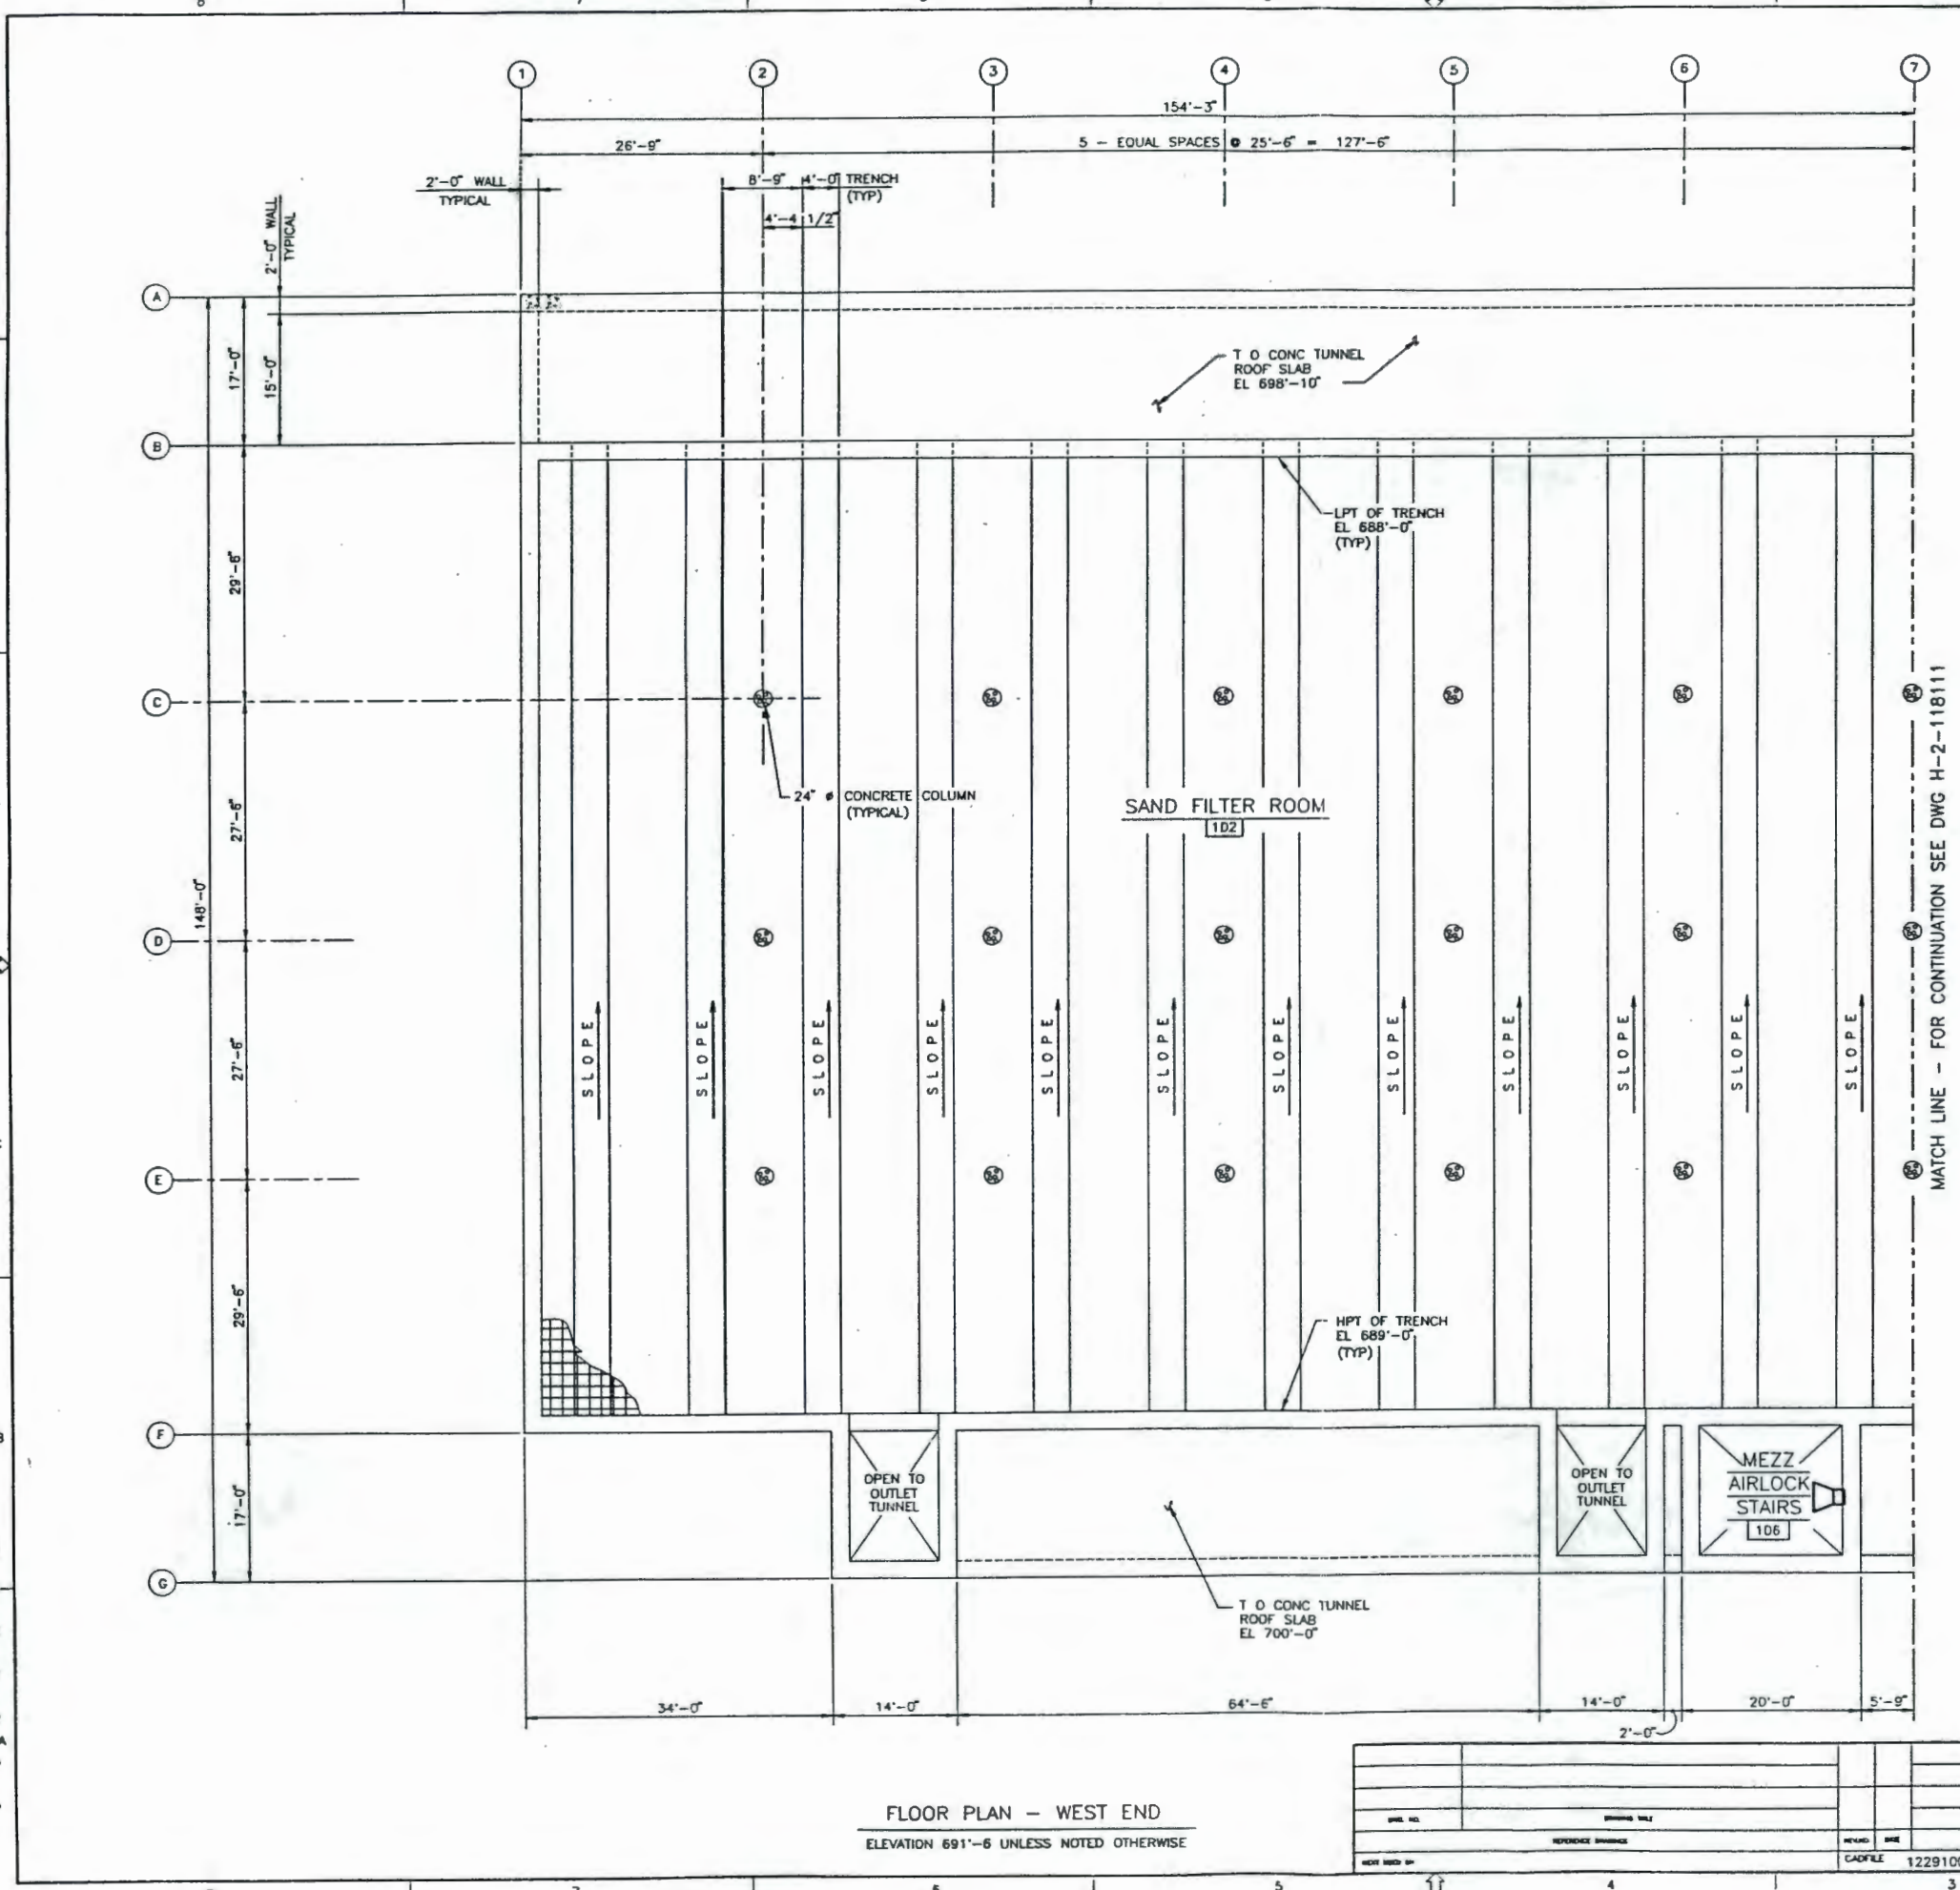

- SYMBOLS
- TELEPHONE OUTLET
 - PUBLIC ADDRESS SPEAKER

REFERENCE
JUL 30 1990

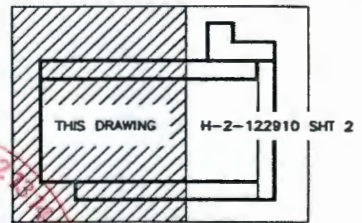

AUG 1990
RECEIVED
EDMC

123456789101112
1314151617181920212223242526272829303132

NOTE:
THIS DRAWING IS ISSUED FOR LOCATION OF COMMUNICATIONS DEVICES ONLY.

FLOOR PLAN - WEST END
ELEVATION 691'-6 UNLESS NOTED OTHERWISE

ENGINEERING RELEASE		U.S. DEPARTMENT OF ENERGY	
REV.	DATE	Regional Operations Office DE - ACCO-90PL10830	
REV.	DATE	FLUOR DANIEL INC. ADVANCED TECHNOLOGY DIVISION	
DESIGNED BY R. GIBBONS	DATE 7-21-90	ELECTRICAL COMMUNICATIONS SYSTEMS LAYOUT SAND FILTER BLDG BASEMENT PLAN	
CHECKED BY C. CHAWLA	DATE 7-21-90	HANFORD WASTE VITRIFICATION PLANT	
APPROVED BY E. BROOKS	DATE 7-21-90	PROJECT NO. B-595	PLANT OFFICE NO. 845724
DATE PLOTTED J. SMETS	DATE 7-21-90	PLANT NO. 3110	SCALE 1/8" = 1'-0"
DATE MARKED K. OWREY	DATE 7-21-90	REVISIONS	REV. NO.
DATE CHECKED S. CLARK	DATE 7-21-90	1	2
DATE T. SWAN	DATE 7-21-90	NONE NOT REQ'D	
DATE K. OWREY	DATE 7-21-90	H-2-122910	
DATE S. CLARK	DATE 7-21-90	1 2 A	

NO.	DATE	DESCRIPTION	BY	CHKD	APP'D

CAD/CNO: 12291001


0010210
2 of 2

ITEM NO	EQUIPMENT NUMBER	HEIGHT	DESCRIPTION
1	DI-058-001		ISOLATION DAMPER
2	DI-058-003		ISOLATION DAMPER
			ISOLATION DAMPER

- SYMBOLS**
- ▶ TELEPHONE OUTLET
 - ◁ PUBLIC ADDRESS SPEAKER


REFERENCE

JUL 30 1990

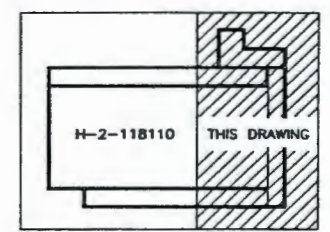

KEY PLAN

NOTE:
THIS DRAWING IS ISSUED FOR
LOCATION OF COMMUNICATIONS
DEVICES ONLY.

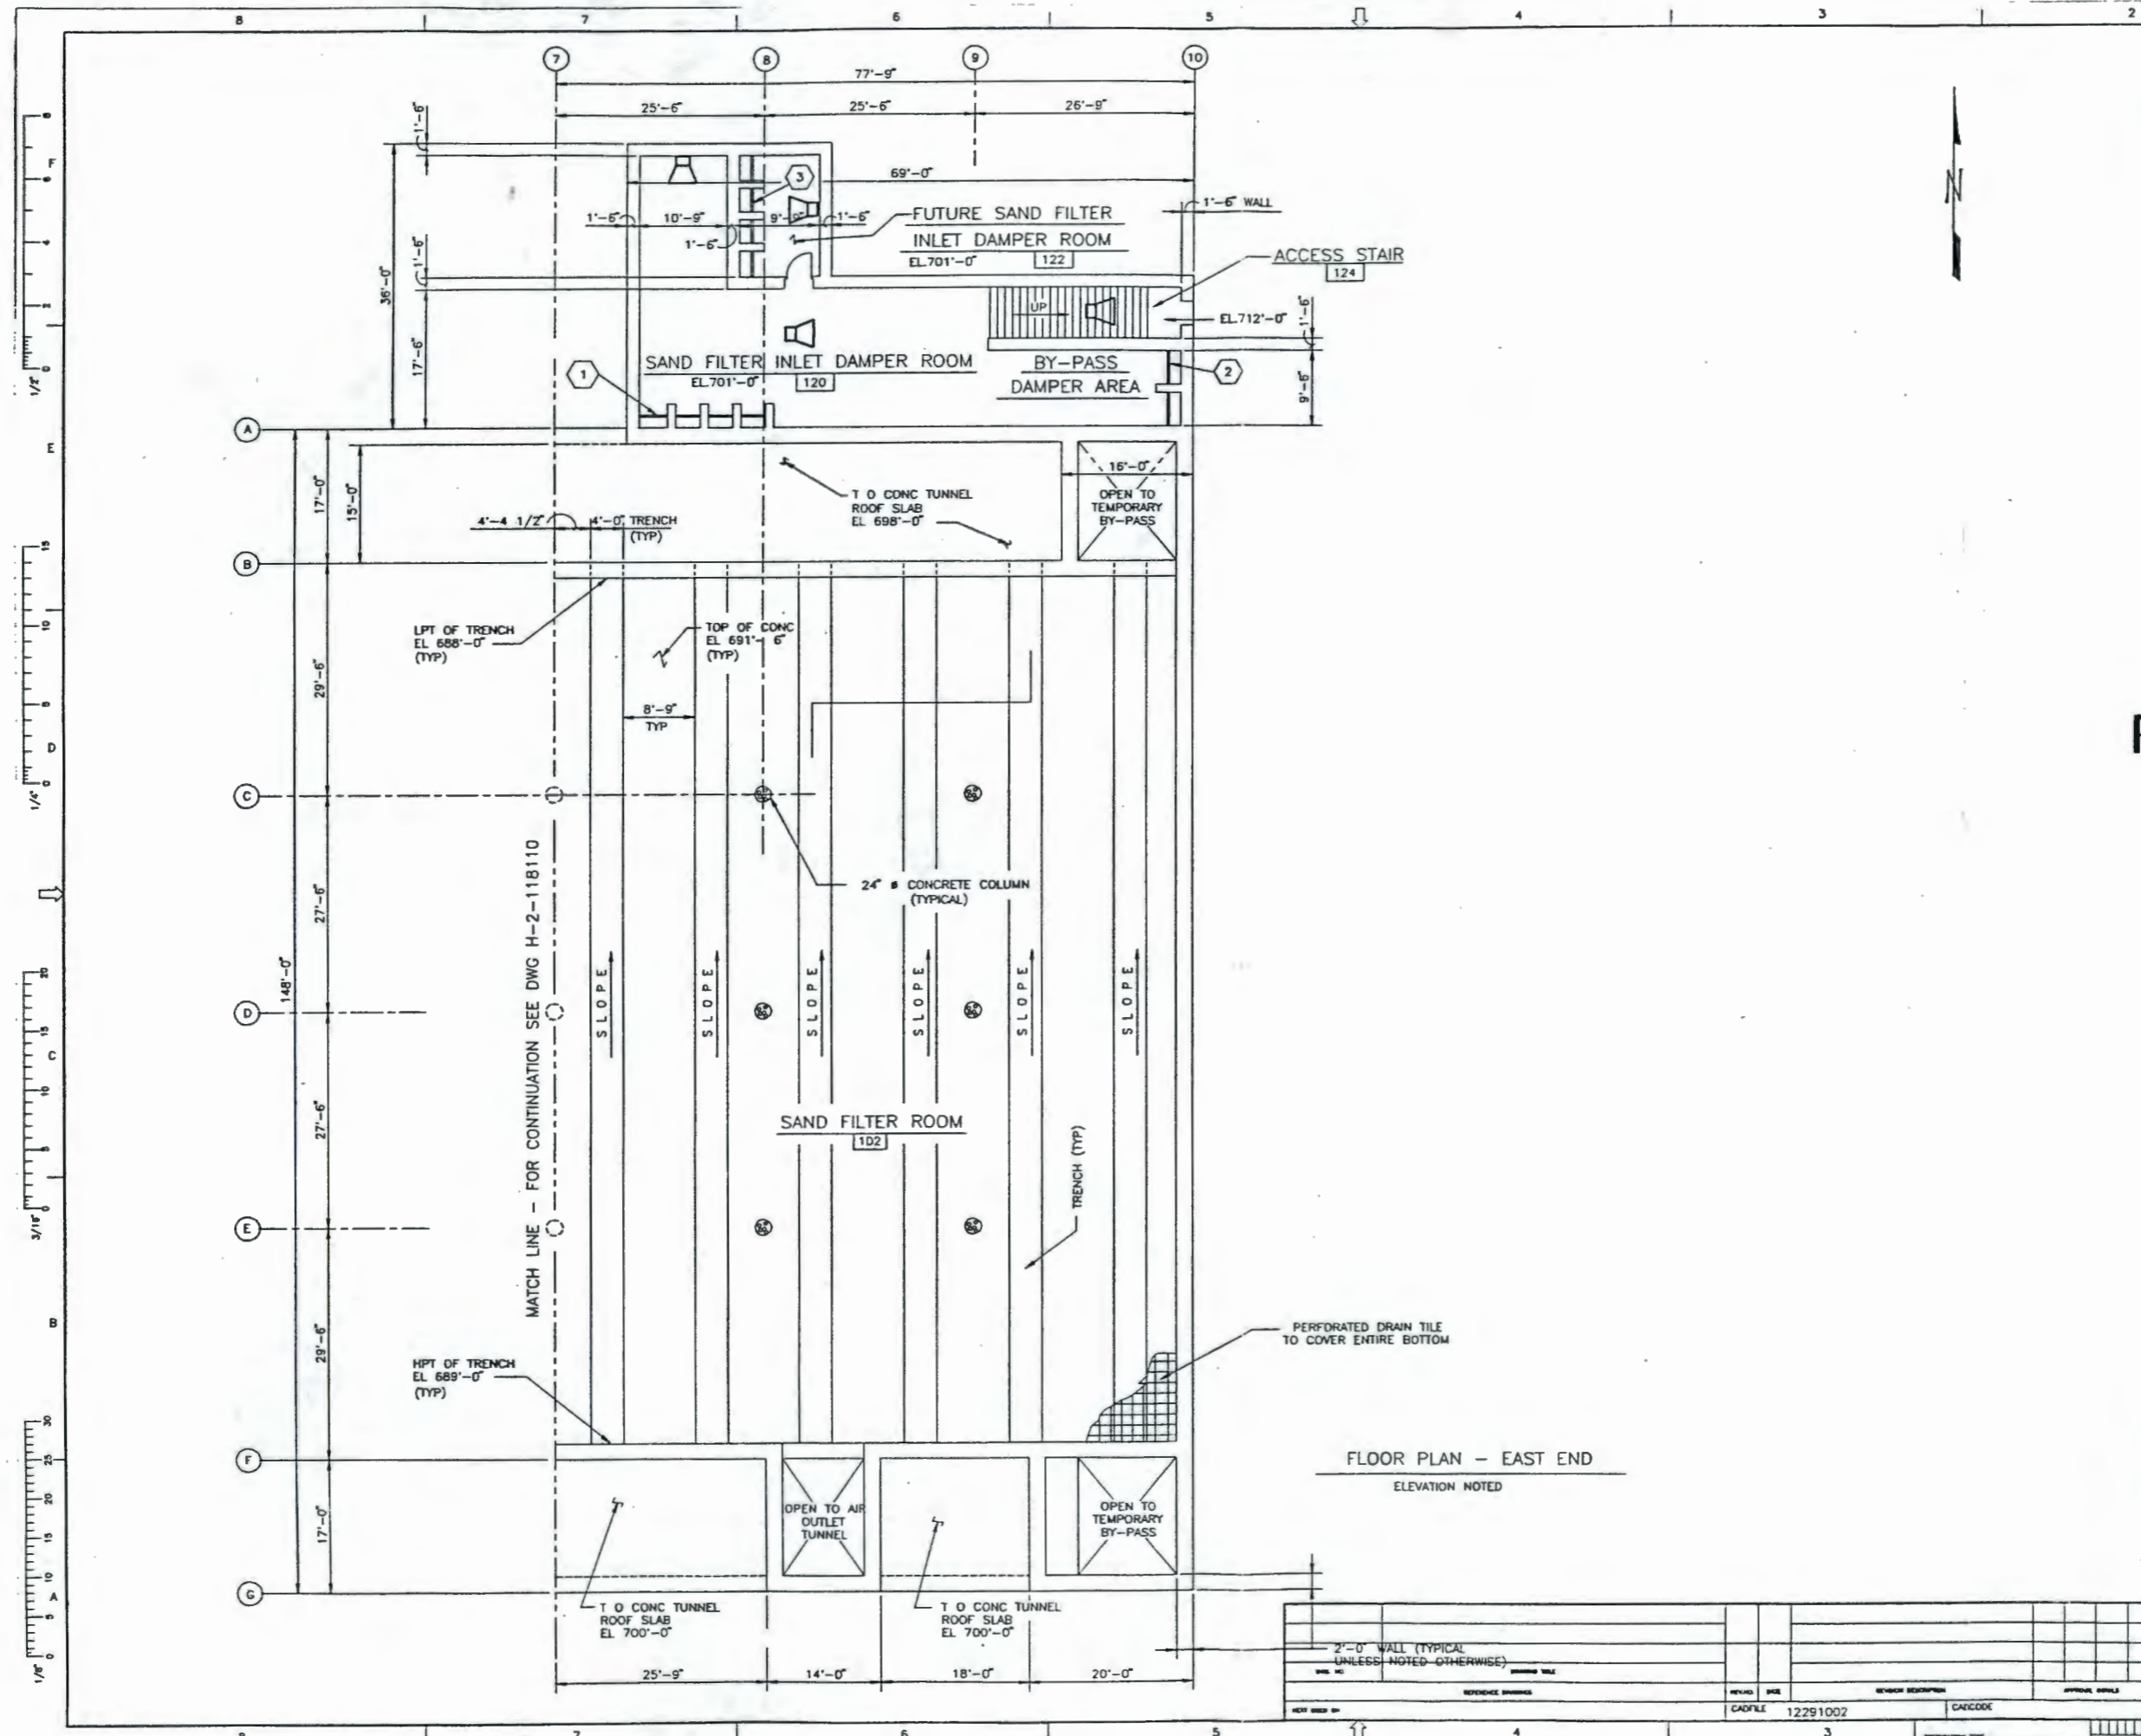

FLOOR PLAN - EAST END
ELEVATION NOTED

ENGINEERING RELEASE		U.S. DEPARTMENT OF ENERGY	
REV	DATE	Regional Operations Office DE - AC08-89PL10036	
ERD		FLUOR DANIEL INC. ADVANCED TECHNOLOGY DIVISION	
SIGNATURE	DATE	ELECTRICAL COMMUNICATIONS SYSTEMS LAYOUT SAND FILTER BLDG BASEMENT - EAST END	
DESIGNED BY R. GIBBONS		PROJECT NO. HANFORD WASTE VITRIFICATION PLANT	
CHECKED BY O. CHAWLA		FLUOR PROJECT NO. B-595	DATE 7-27-90
CONSTRUCTED BY F. BROOKS		FLUOR CONTRACT NO. B-45724	DATE 7-27-90
SYSTEMS BY J. SMETS		FLUOR NO. 3110	SCALE 1/8" = 1'-0"
DATE K. DWREY 7-27-90		SHEET NO. 2	
APPROVED BY S. CLARK 7-27-90		TOTAL SHEETS 2	
DATE K. DWREY 7-27-90		SHEET NO. 2	
APPROVED BY S. CLARK 7-27-90		TOTAL SHEETS 2	
DATE K. DWREY 7-27-90		SHEET NO. A	
APPROVED BY S. CLARK 7-27-90		TOTAL SHEETS 2	

91118901773