


0010208
1 of 2

START

91118901769

EQUIPMENT LIST			
ITEM NO	EQUIPMENT NUMBER	HEIGHT FEET	DESCRIPTION

ROOM INDEX	
ROOM NUMBER	ROOM NAME
102	ENTRY
104	FIELD OPERATING STATION - 07
106	BATTERY ROOM
108	ELECTRICAL ROOM
110	ELECTRICAL ROOM
112	ENTRY
114	VESTIBULE
116	EXHAUST TUNNEL
117	HEPA FILTER STORAGE
118	INLET TUNNEL
202	ENTRY
204	SAMPLING STATION INSTRUMENT RACKS
206	HVAC EQUIPMENT ROOM
208	BALCONY
210	ZONE 1 EXHAUST FAN ROOM
216	FAN ROOM
218	FAN ROOM

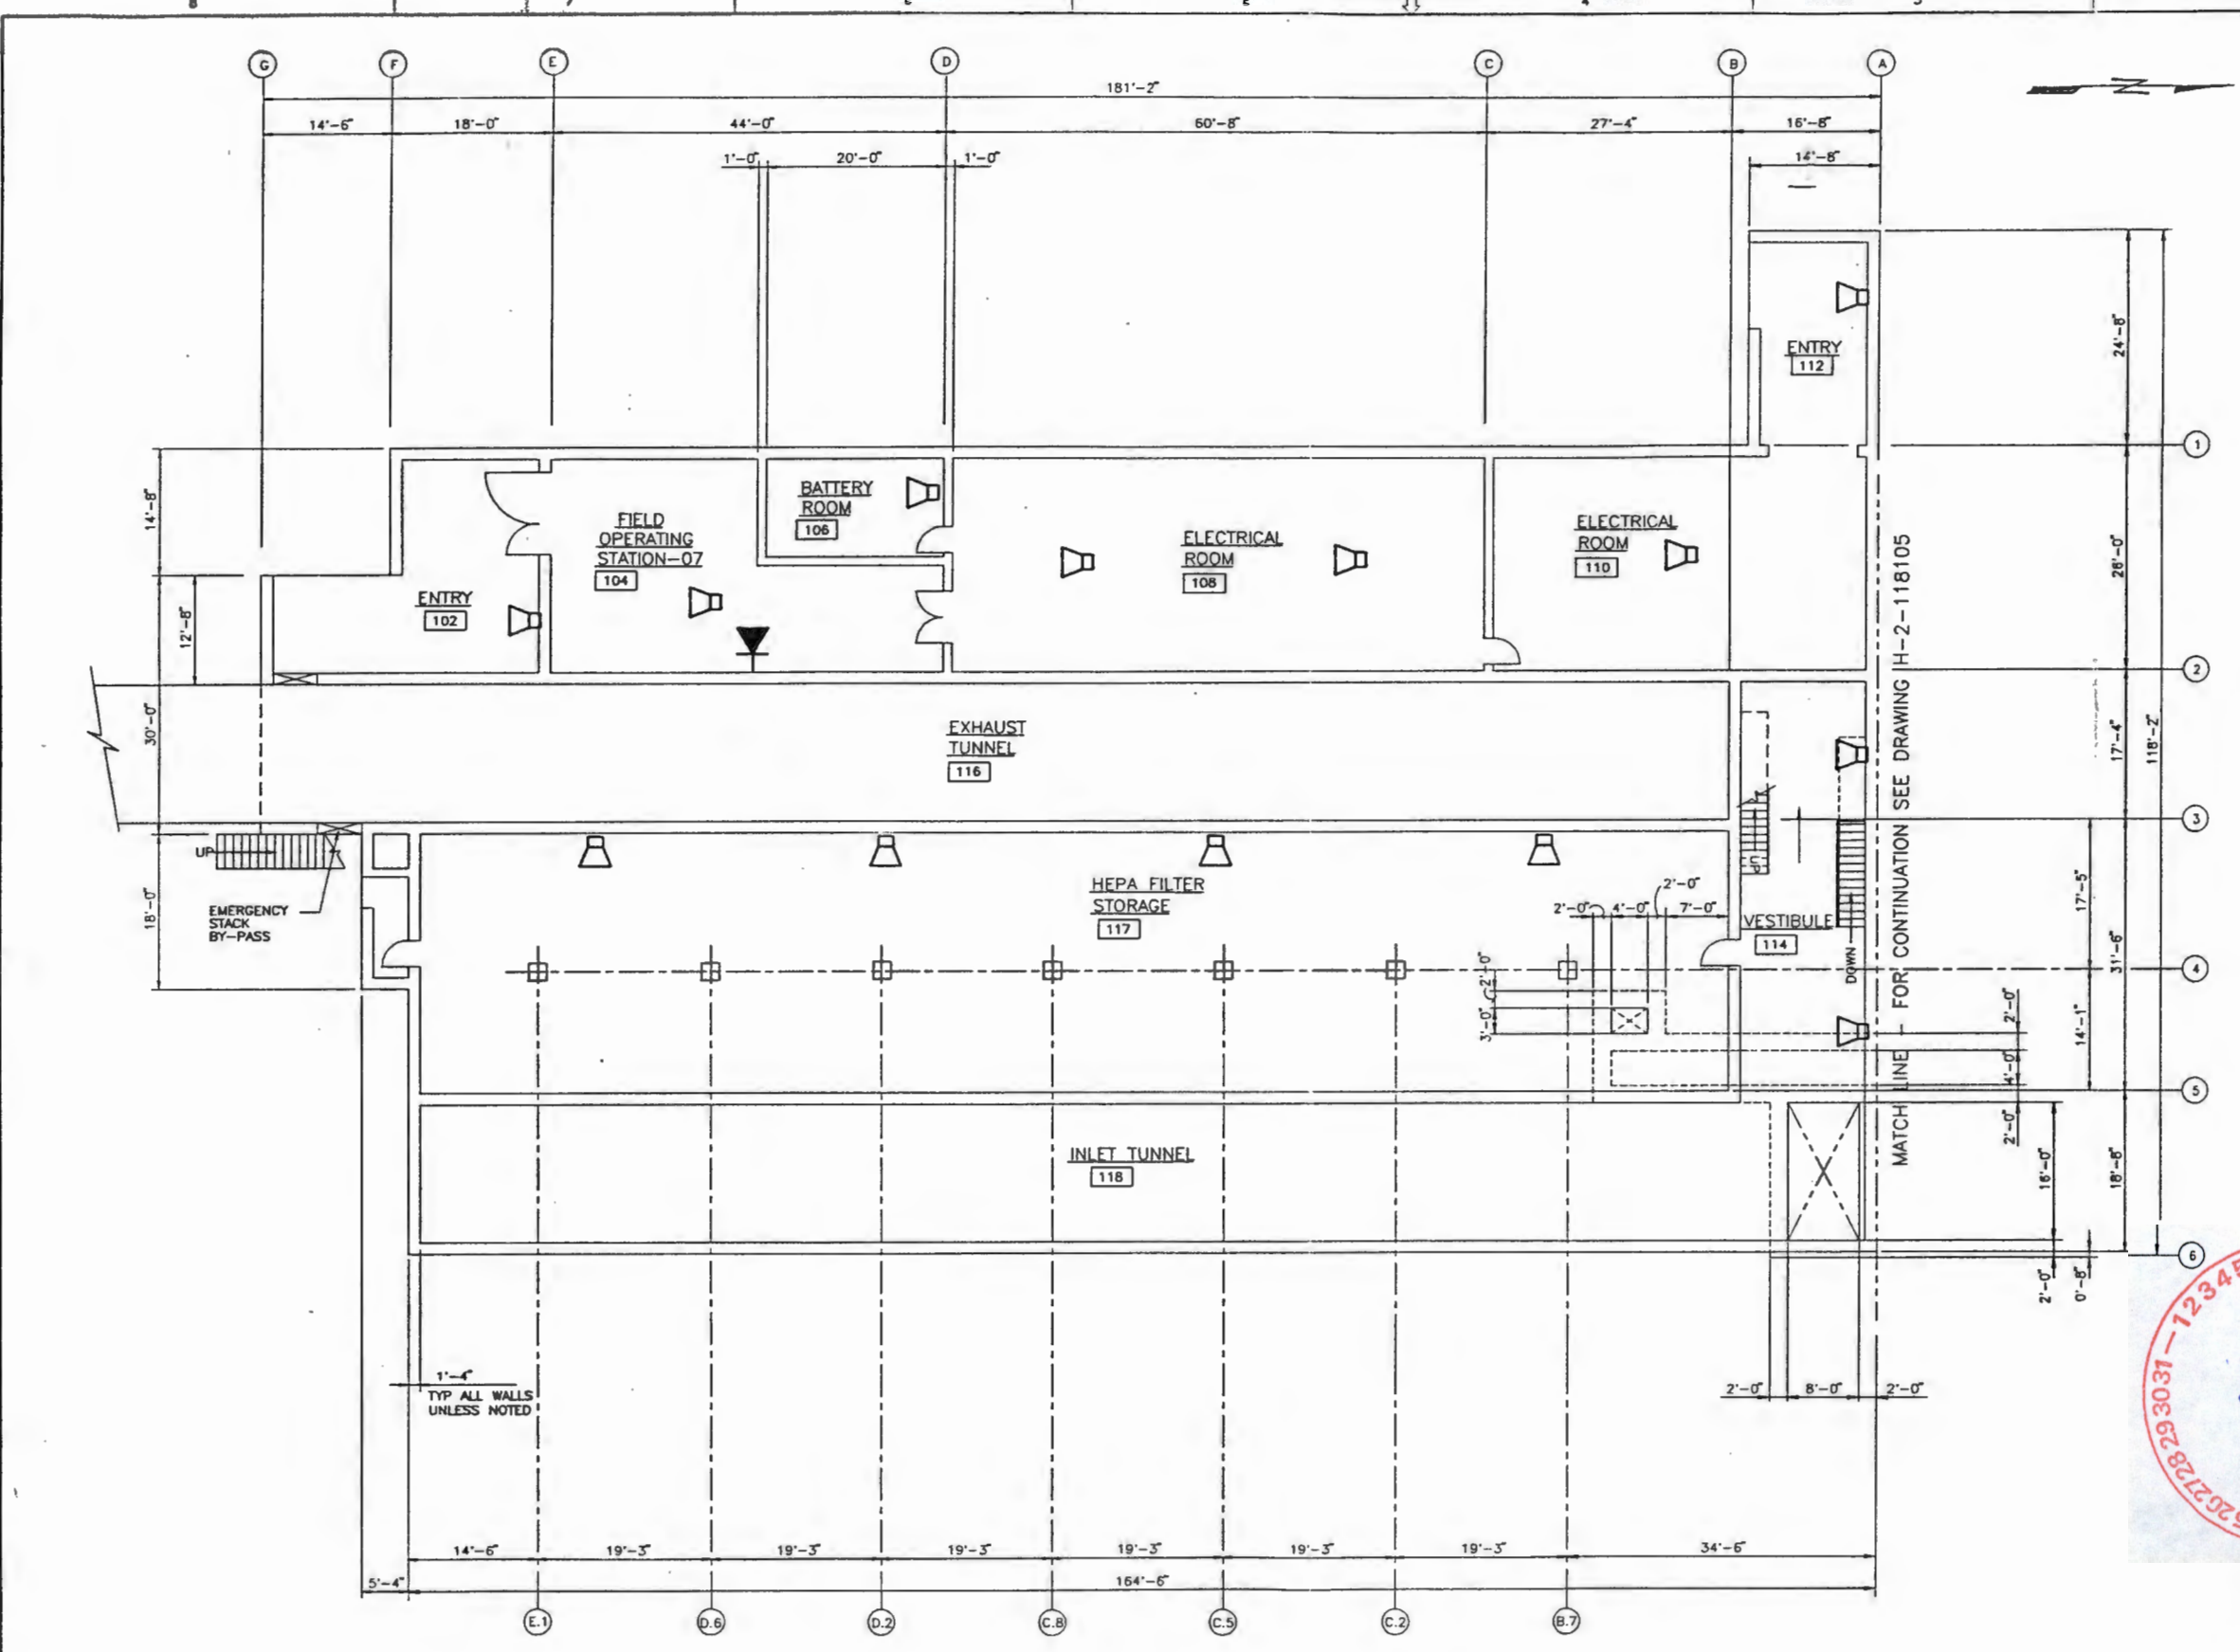

REFERENCE

JUL 30 1990

- SYMBOLS**
- ☐ TELEPHONE OUTLET
 - ☐ PUBLIC ADDRESS SPEAKER



NOTE:
THIS DRAWING IS ISSUED FOR LOCATION OF COMMUNICATIONS DEVICES ONLY.

FIRST FLOOR PLAN - EL 712'-0" UNLESS NOTED OTHERWISE

NOTE:

1. FOR NOTES SEE DRAWING H-2-118105.

U.S. DEPARTMENT OF ENERGY National Operations Office DE - ACCB-0881108.38	
FLUOR DANIEL, INC. ADVANCED TECHNOLOGY DIVISION ELECTRICAL COMMUNICATIONS SYSTEMS LAYOUT FAN HOUSE FIRST FLOOR	
PROJECT NO. HANFORD WASTE VITRIFICATION PLANT DRAWING NO. B-595 SHEET NO. 845724 SCALE 1/8" = 1'-0"	PROJECT BILL SHEET NO. 3110 SHEET NO. 1 OF 2 DATE 7/27/90
REVISIONS: REV. NO. DATE DESCRIPTION 1. NONE 2. NOT REQ'D	CAD FILE 12290701 CADDCS:




0010208
20F2


ITEM NO.	EQUIPMENT NUMBER	HEIGHT FEET	DESCRIPTION

REFERENCE

JUL 30 1990

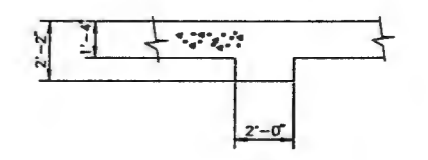


SECTION C
SCALE: 3/8" = 1'-0"

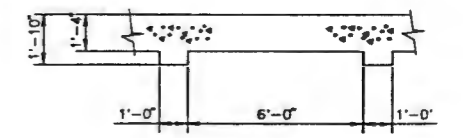

SECTION D
SCALE: 3/8" = 1'-0"

NOTE:
THIS DRAWING IS ISSUED FOR
LOCATION OF COMMUNICATIONS
DEVICES ONLY.

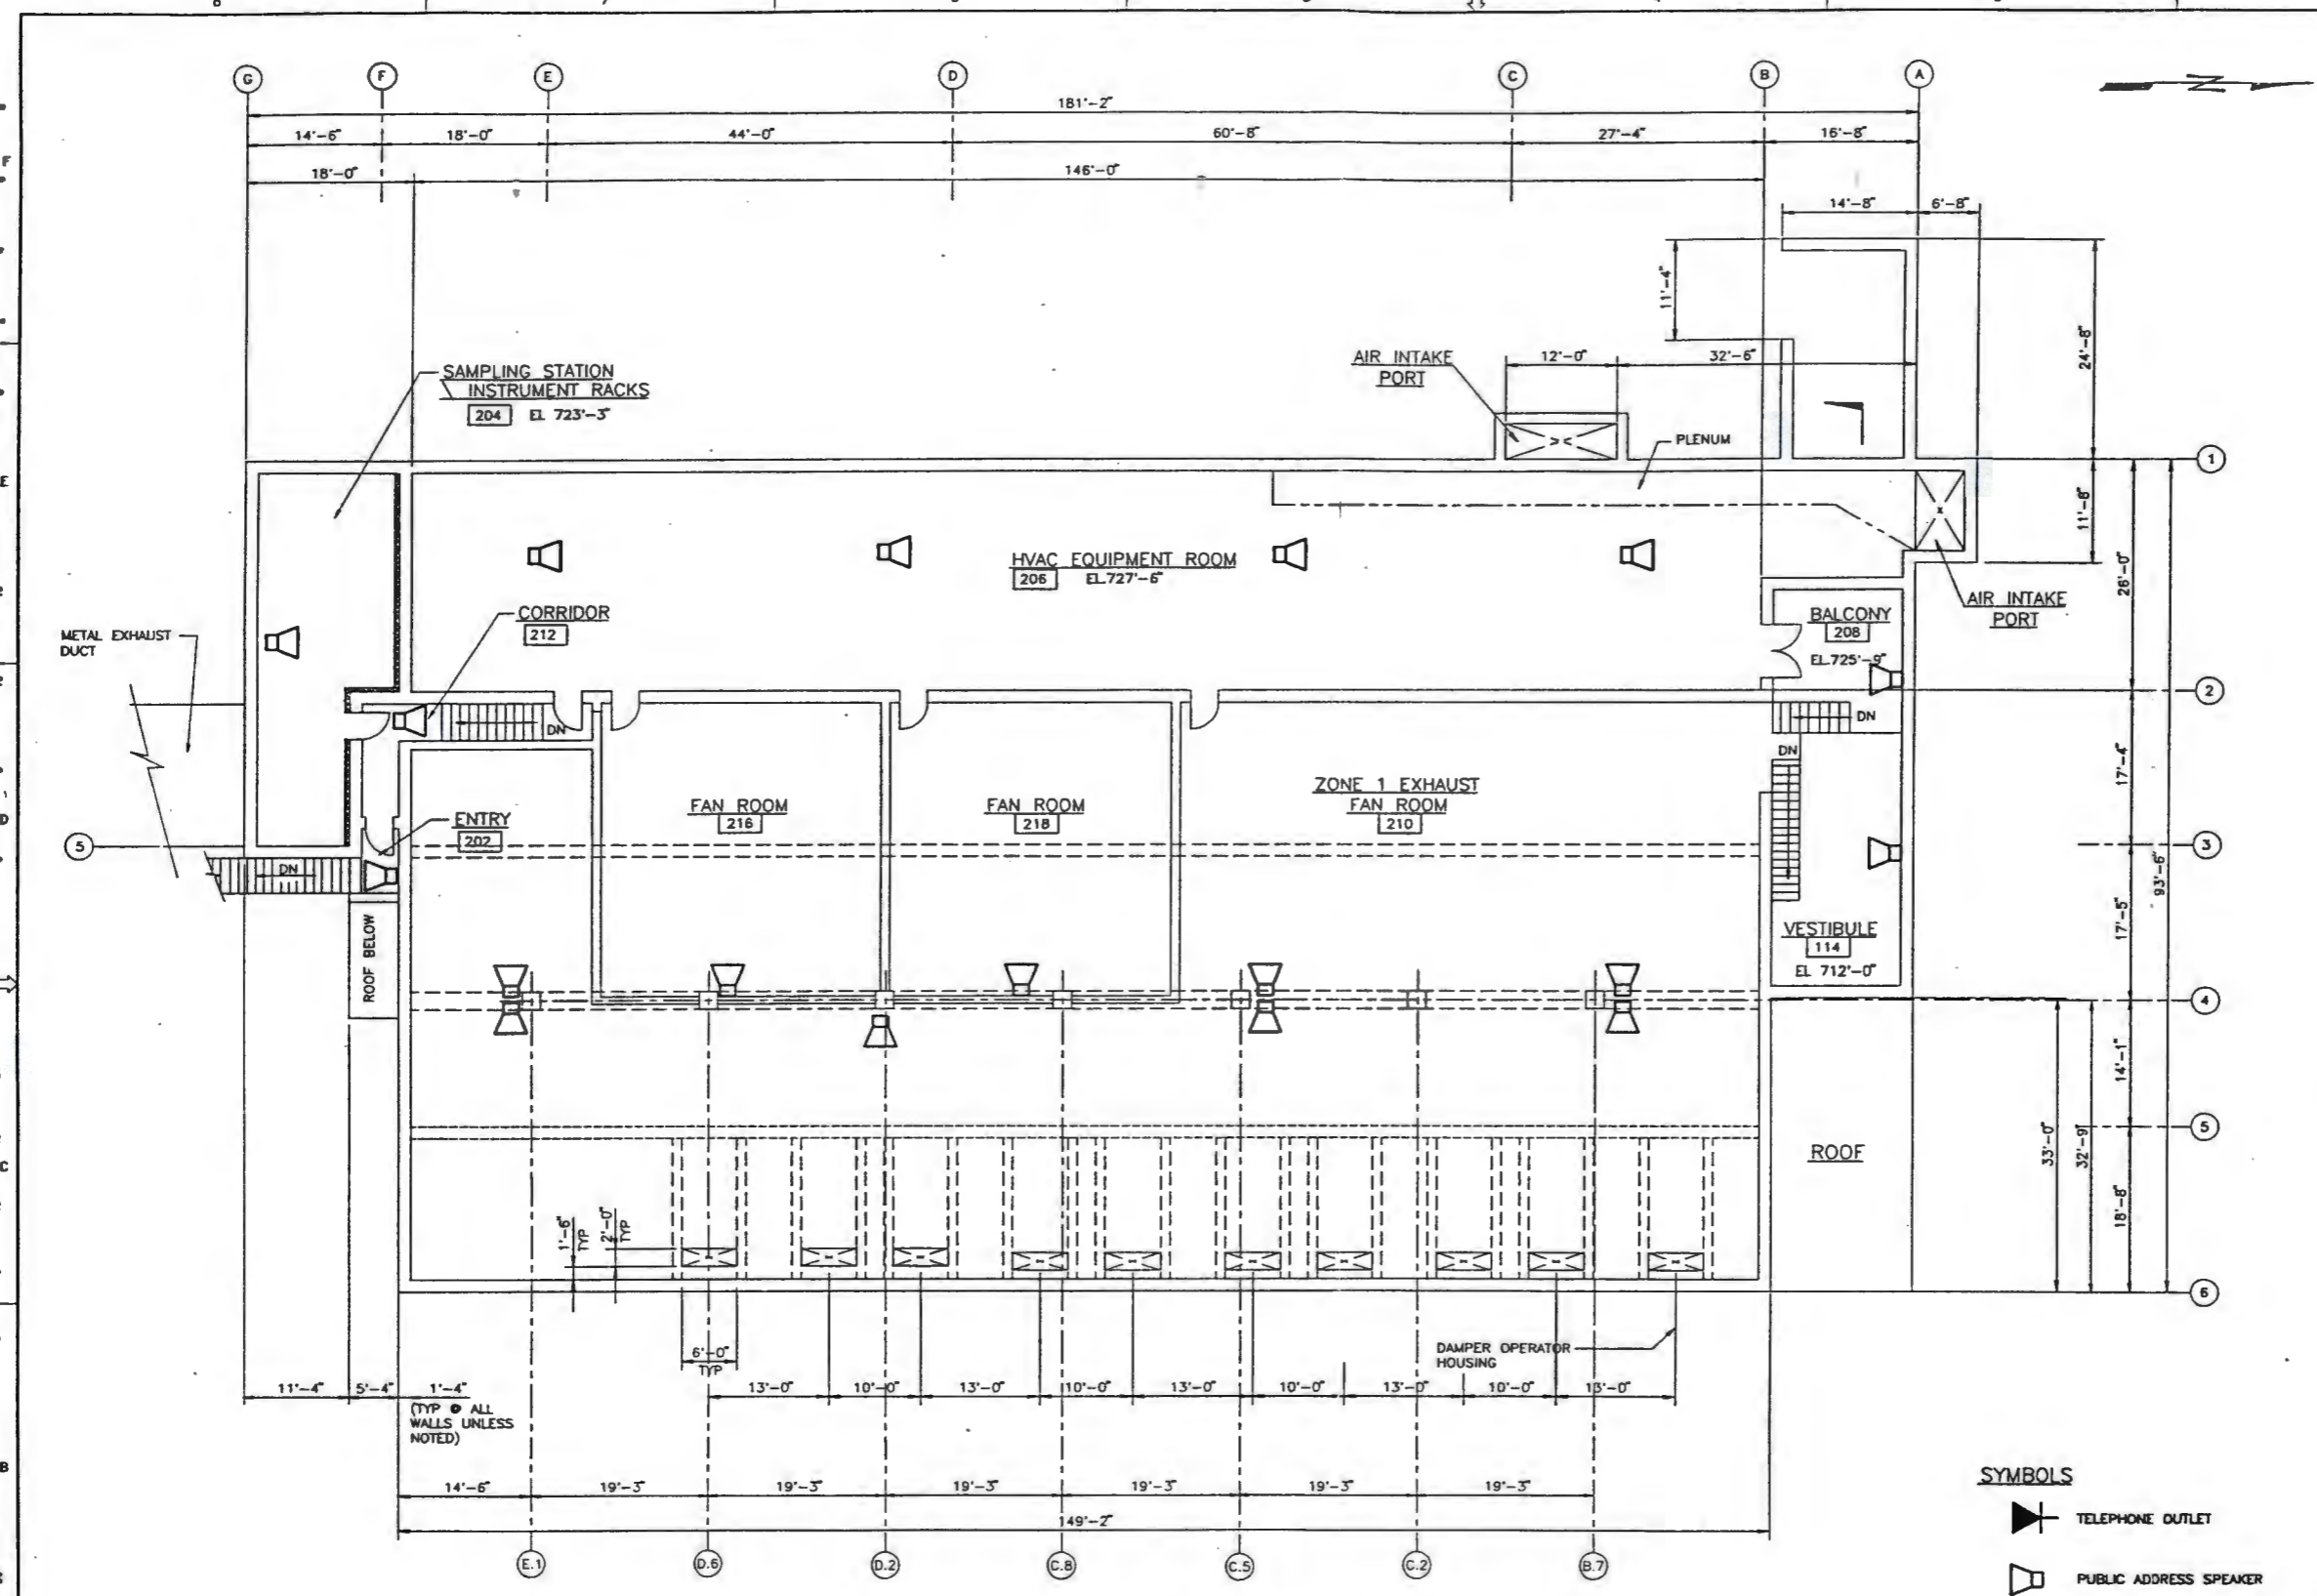

- SYMBOLS**
- TELEPHONE OUTLET
 - PUBLIC ADDRESS SPEAKER

SECOND FLOOR PLAN - EL 721'-6" UNLESS NOTED OTHERWISE

ENGINEERING RELEASE		U.S. DEPARTMENT OF ENERGY	
REV.	DATE	Advanced Technology Office EE - AC00-DEPL10030	
DESIGNED BY	DATE	FLUOR DANIEL INC. ADVANCED TECHNOLOGY DIVISION	
DRAWN BY	DATE	ELECTRICAL COMMUNICATIONS SYSTEMS LAYOUT	
CHECKED BY	DATE	FAN HOUSE SECOND FLOOR	
PROJECT NO.	DATE	HANFORD WASTE VITRIFICATION PLANT	
REVISED BY	DATE	PROJECT NO.	3110
DATE	DATE	REVISED BY	B-595
DATE	DATE	PROJECT NO.	B45724
DATE	DATE	REVISED BY	3110
DATE	DATE	PROJECT NO.	1/8" = 1'-0"
DATE	DATE	REVISED BY	
DATE	DATE	PROJECT NO.	
DATE	DATE	REVISED BY	
DATE	DATE	PROJECT NO.	

NO.	DATE	DESCRIPTION	APPROVAL

91118901770