



START

EQUIPMENT LIST			
ITEM NO	EQUIPMENT NUMBER	HEIGHT FEET	DESCRIPTION



REFERENCE

JUL 19 1990

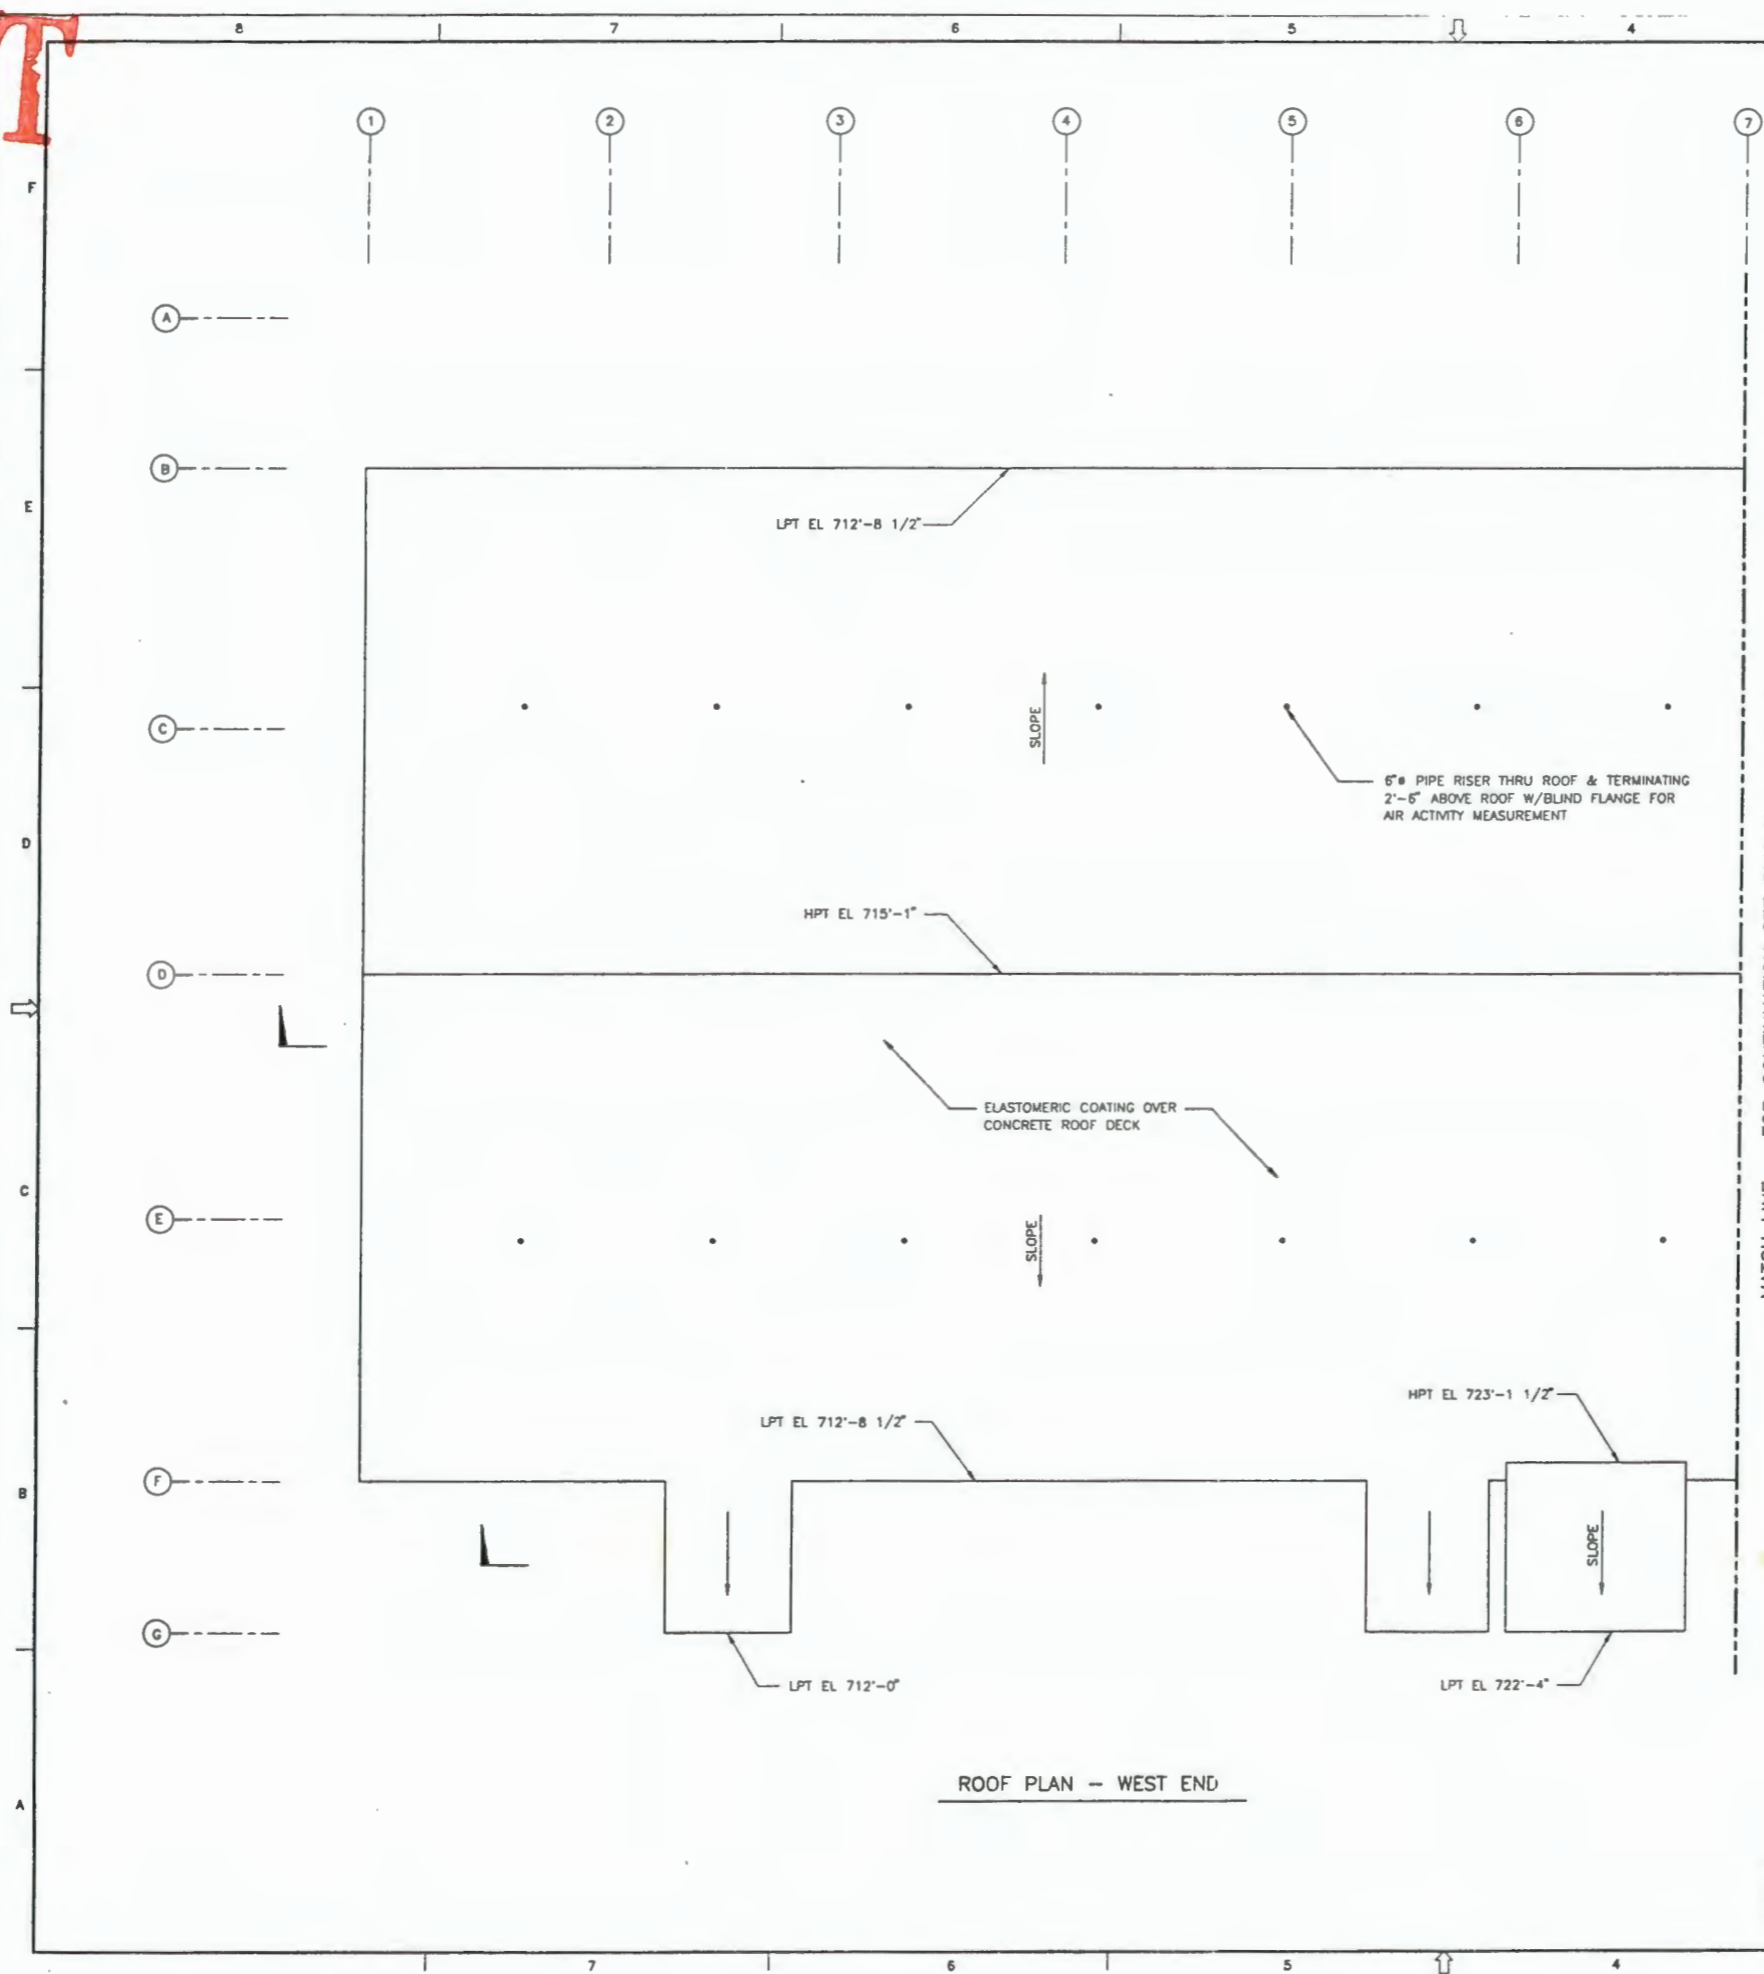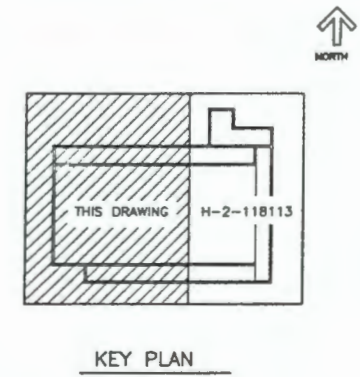

ROOF PLAN -- WEST END

MATCH LINE -- FOR CONTINUATION SEE DWG H-2-118113



NOTE:
1. FOR NOTES SEE DRAWING H-2-118109

90118841258

REV. NO.	DATE	REVISION DESCRIPTION	APPROVAL

ENGINEERING RELEASE
REV. DATE

U.S. DEPARTMENT OF ENERGY
Hanford Operations Office
HW-4000-0001-10038

FLUOR DANIEL, INC.
ADVANCED TECHNOLOGY DIVISION

GENERAL ARRANGEMENT
SAND FILTER BUILDING
ROOF PLAN -- WEST END

HANFORD WASTE VERIFICATION PLANT
PROJECT NO. 9-595
PLANT IDENTITY NO. 845724
SHEET NO. 3107
SCALE 1/8" = 1'-0"
SHEET NO. 6

DESIGNED BY V. KOLDRE
CHECKED BY V. KOLDRE

DATE 7/12/90
SCALE 1/8" = 1'-0"

NO. OF SHEETS 1
SHEET NO. 1
TOTAL SHEETS 1

AUTOCAD 1
11 JUL 90
LCO = CEF