



START

91118901782

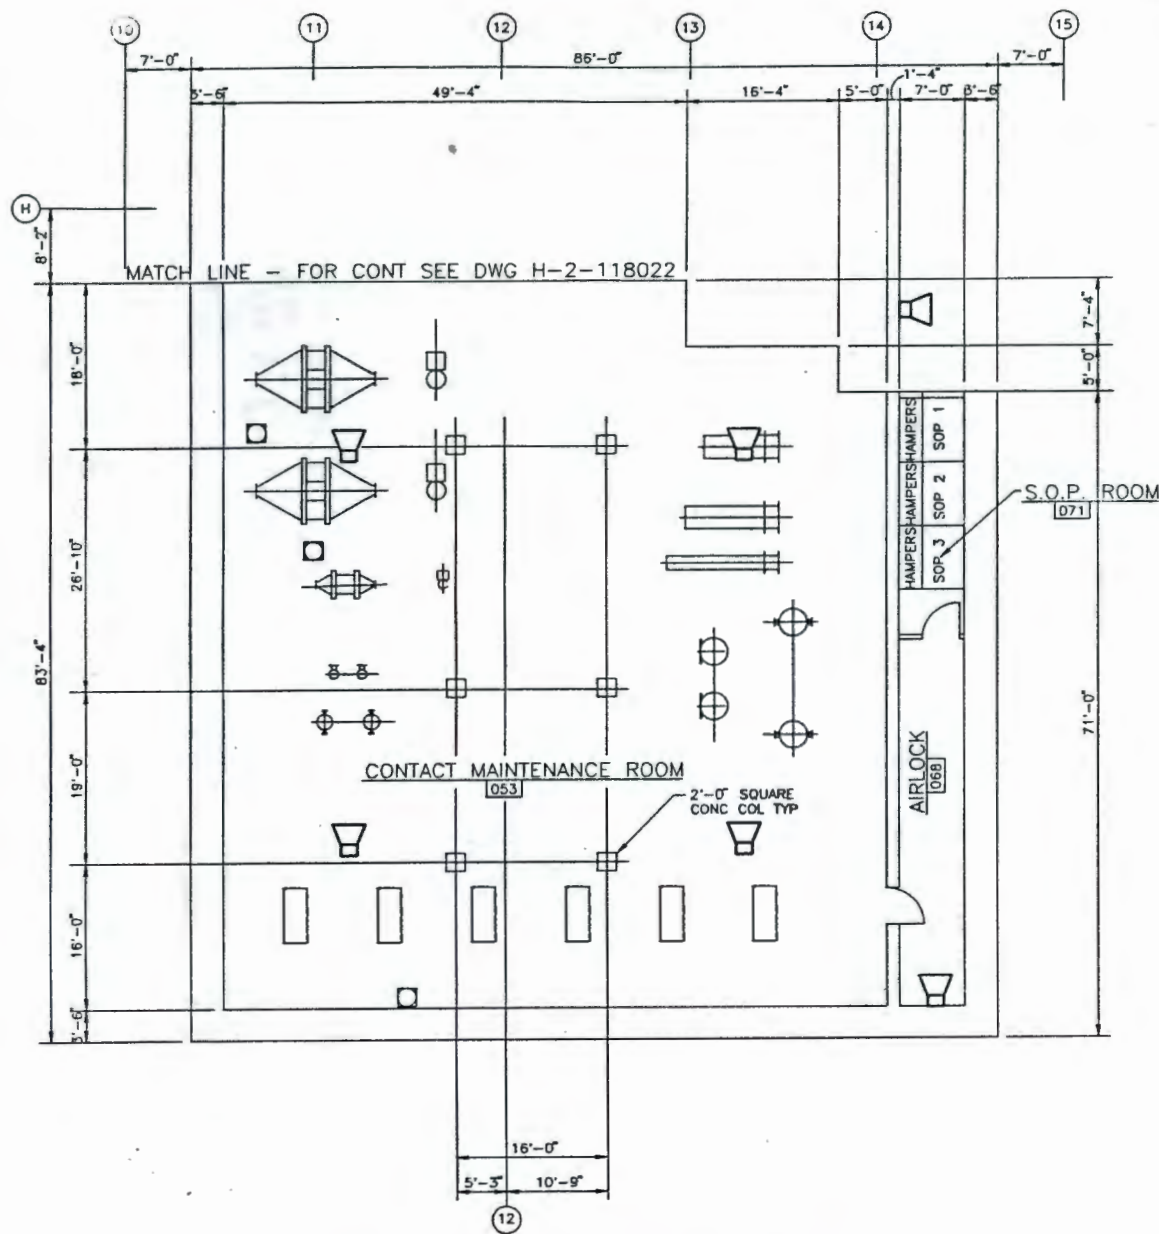

CONTACT MAINTENANCE FLOOR PLAN - EL.676'-6"

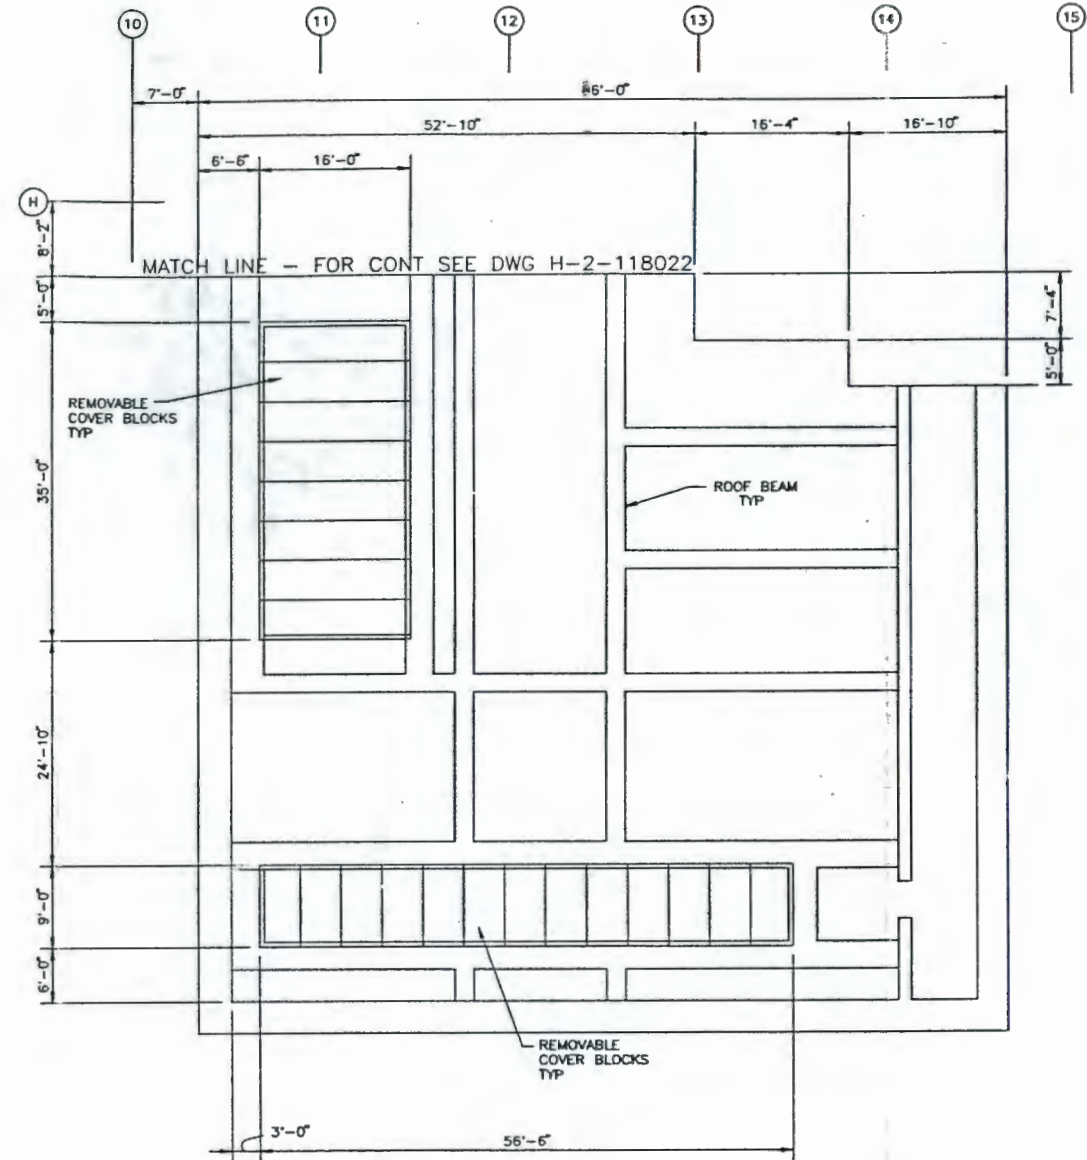


CONTACT MAINTENANCE ROOF PLAN - EL.708'-4" UNLESS NOTED OTHERWISE



REFERENCE

JUL 30 1990

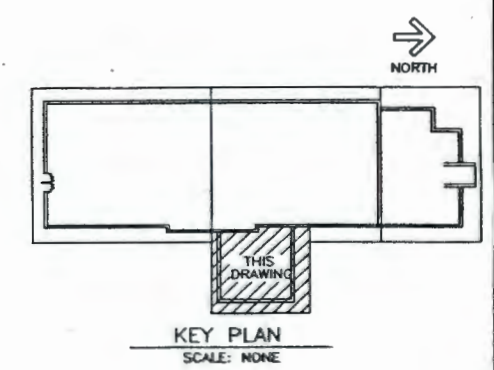

SYMBOLS

- Telephone Outlet symbol
- Public Address Speaker symbol

NOTE:
THIS DRAWING IS ISSUED FOR LOCATION OF COMMUNICATIONS DEVICES ONLY.

ENGINEERING RELEASE		U.S. DEPARTMENT OF ENERGY	
REV.	DATE	Advanced Operations Office DE - ACCG - 80PL 10839	
PROJECT NO. R. GIBBONS O. CHAWLA F. BROOKS J. SMETS K. DWREY S. CLARK		FLUOR DANIEL, INC. ADVANCED TECHNOLOGY DIVISION ELECTRICAL COMMUNICATIONS SYSTEMS LAYOUT CMR BUILDING FLOOR PLAN	
PROJECT TITLE HANFORD WASTE VITRIFICATION PLANT		DRAWING NO. B-595	SHEET NO. 1
DRAWING SCALE 1/8" = 1'		PROJECT NO. H-2-122913	SHEET NO. 1 A

REV. NO.	DESCRIPTION	DATE	BY	APP. NO.

PROJECT NO. H-2-122913
SHEET NO. 1 A